
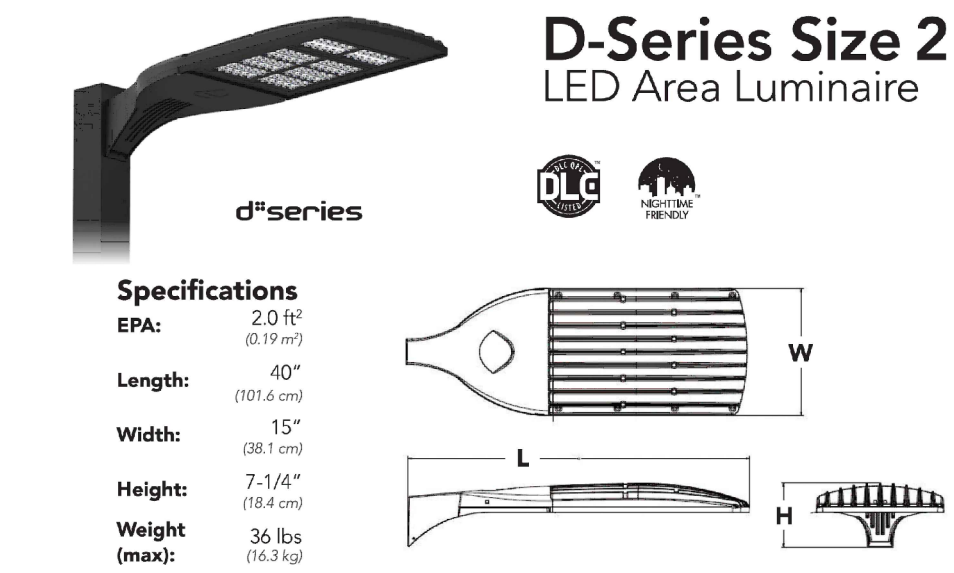


1

E4.0

POLE MOUNTED FIXTURE DETAIL

NOT TO SCALE

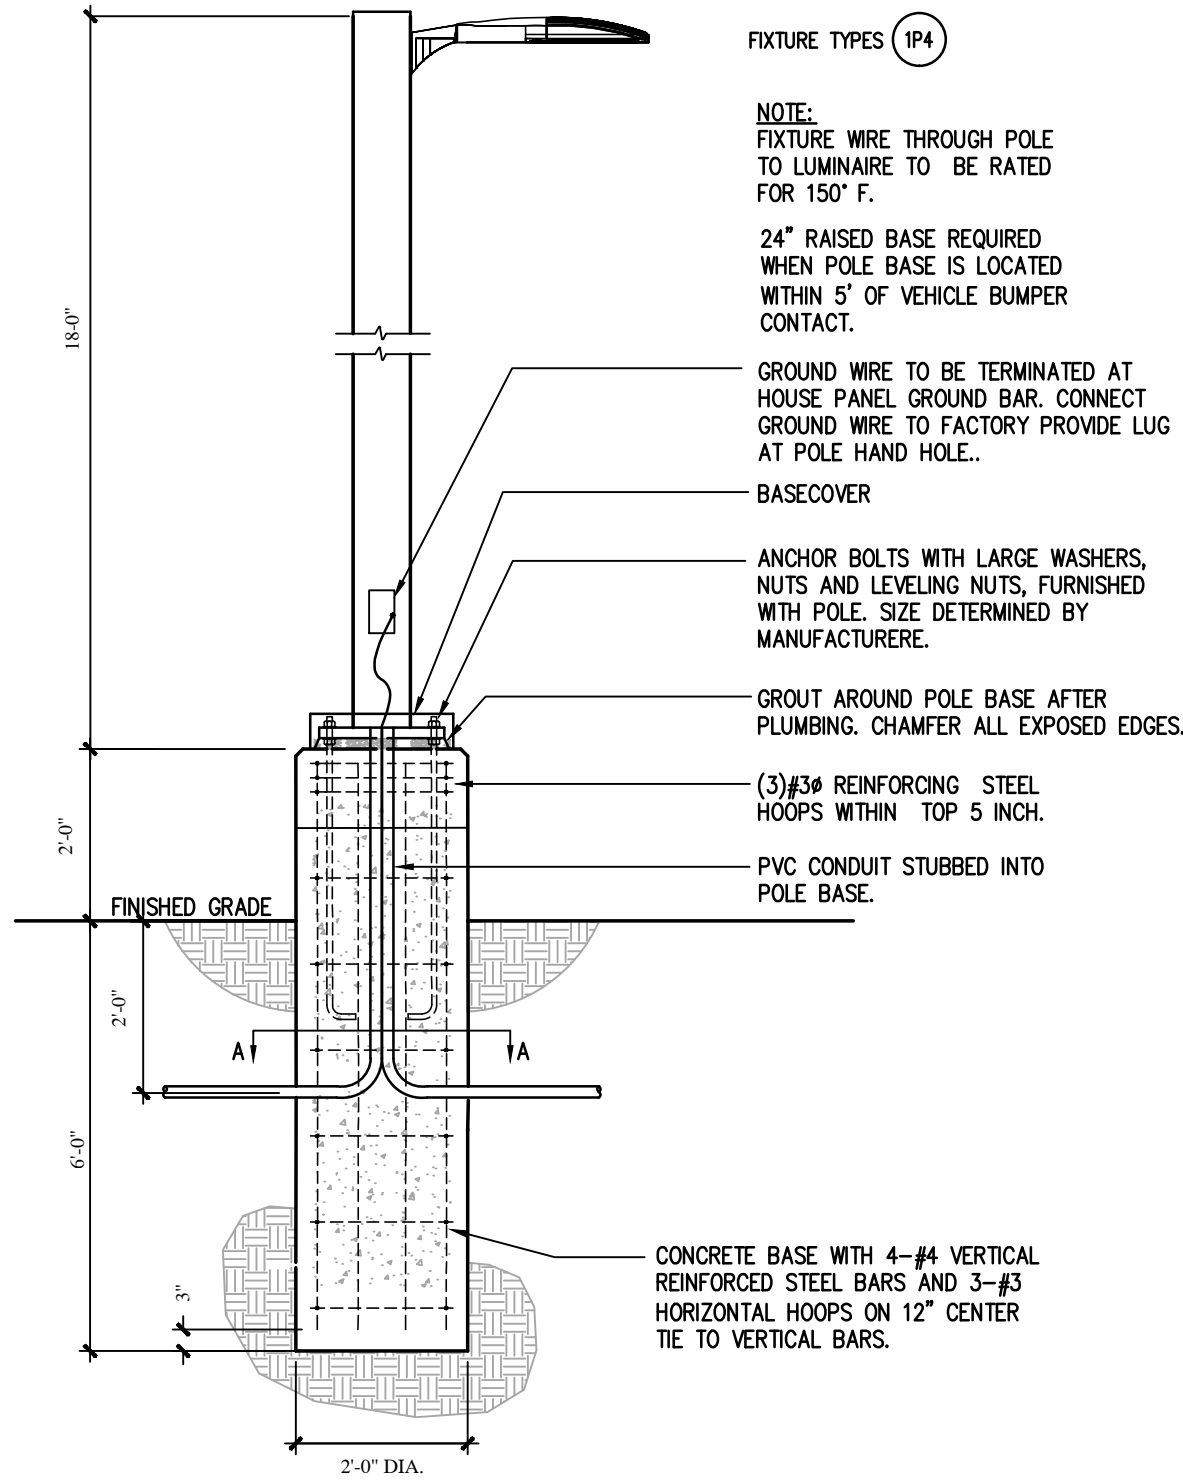


2


E4.0

EXTERIOR WALL MOUNTED LIGHT DETAIL

NOT TO SCALE

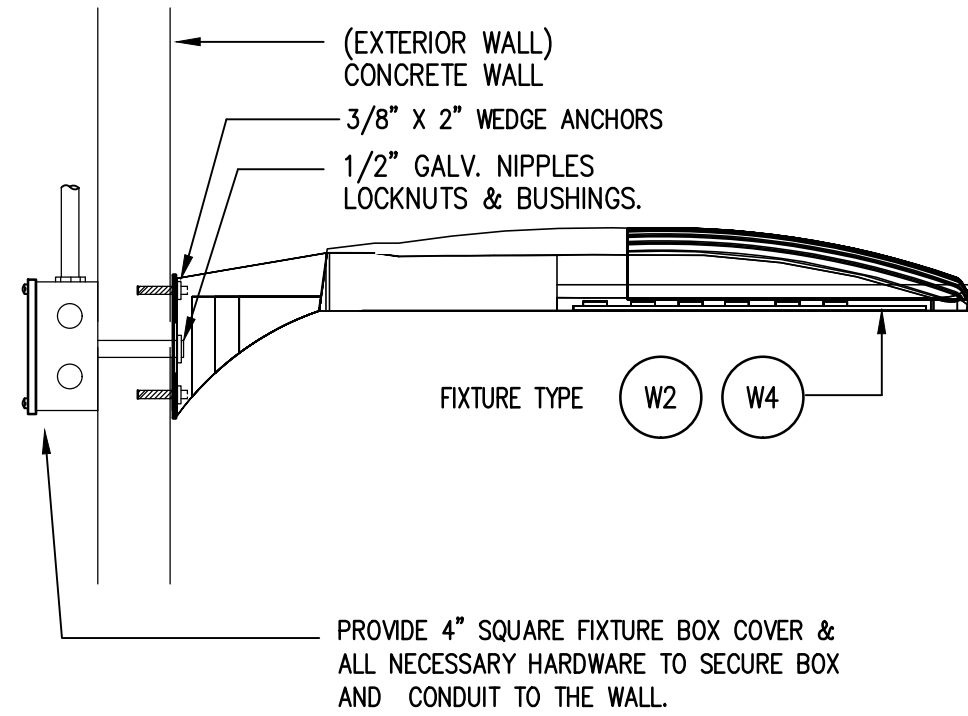

NOTE:
DETERMINE MOUNTING LOCATION OF SPLICE BOX. APPLY A BEAD OF SUITABLE WEATHERPROOF SEALANT ALONG HORIZONTAL TOP AND VERTICAL LEFT AND RIGHT EDGES OF CAST MOUNTING PLATE WHERE IT CONTACTS THE WALL TO PREVENT WATER ENTRY.

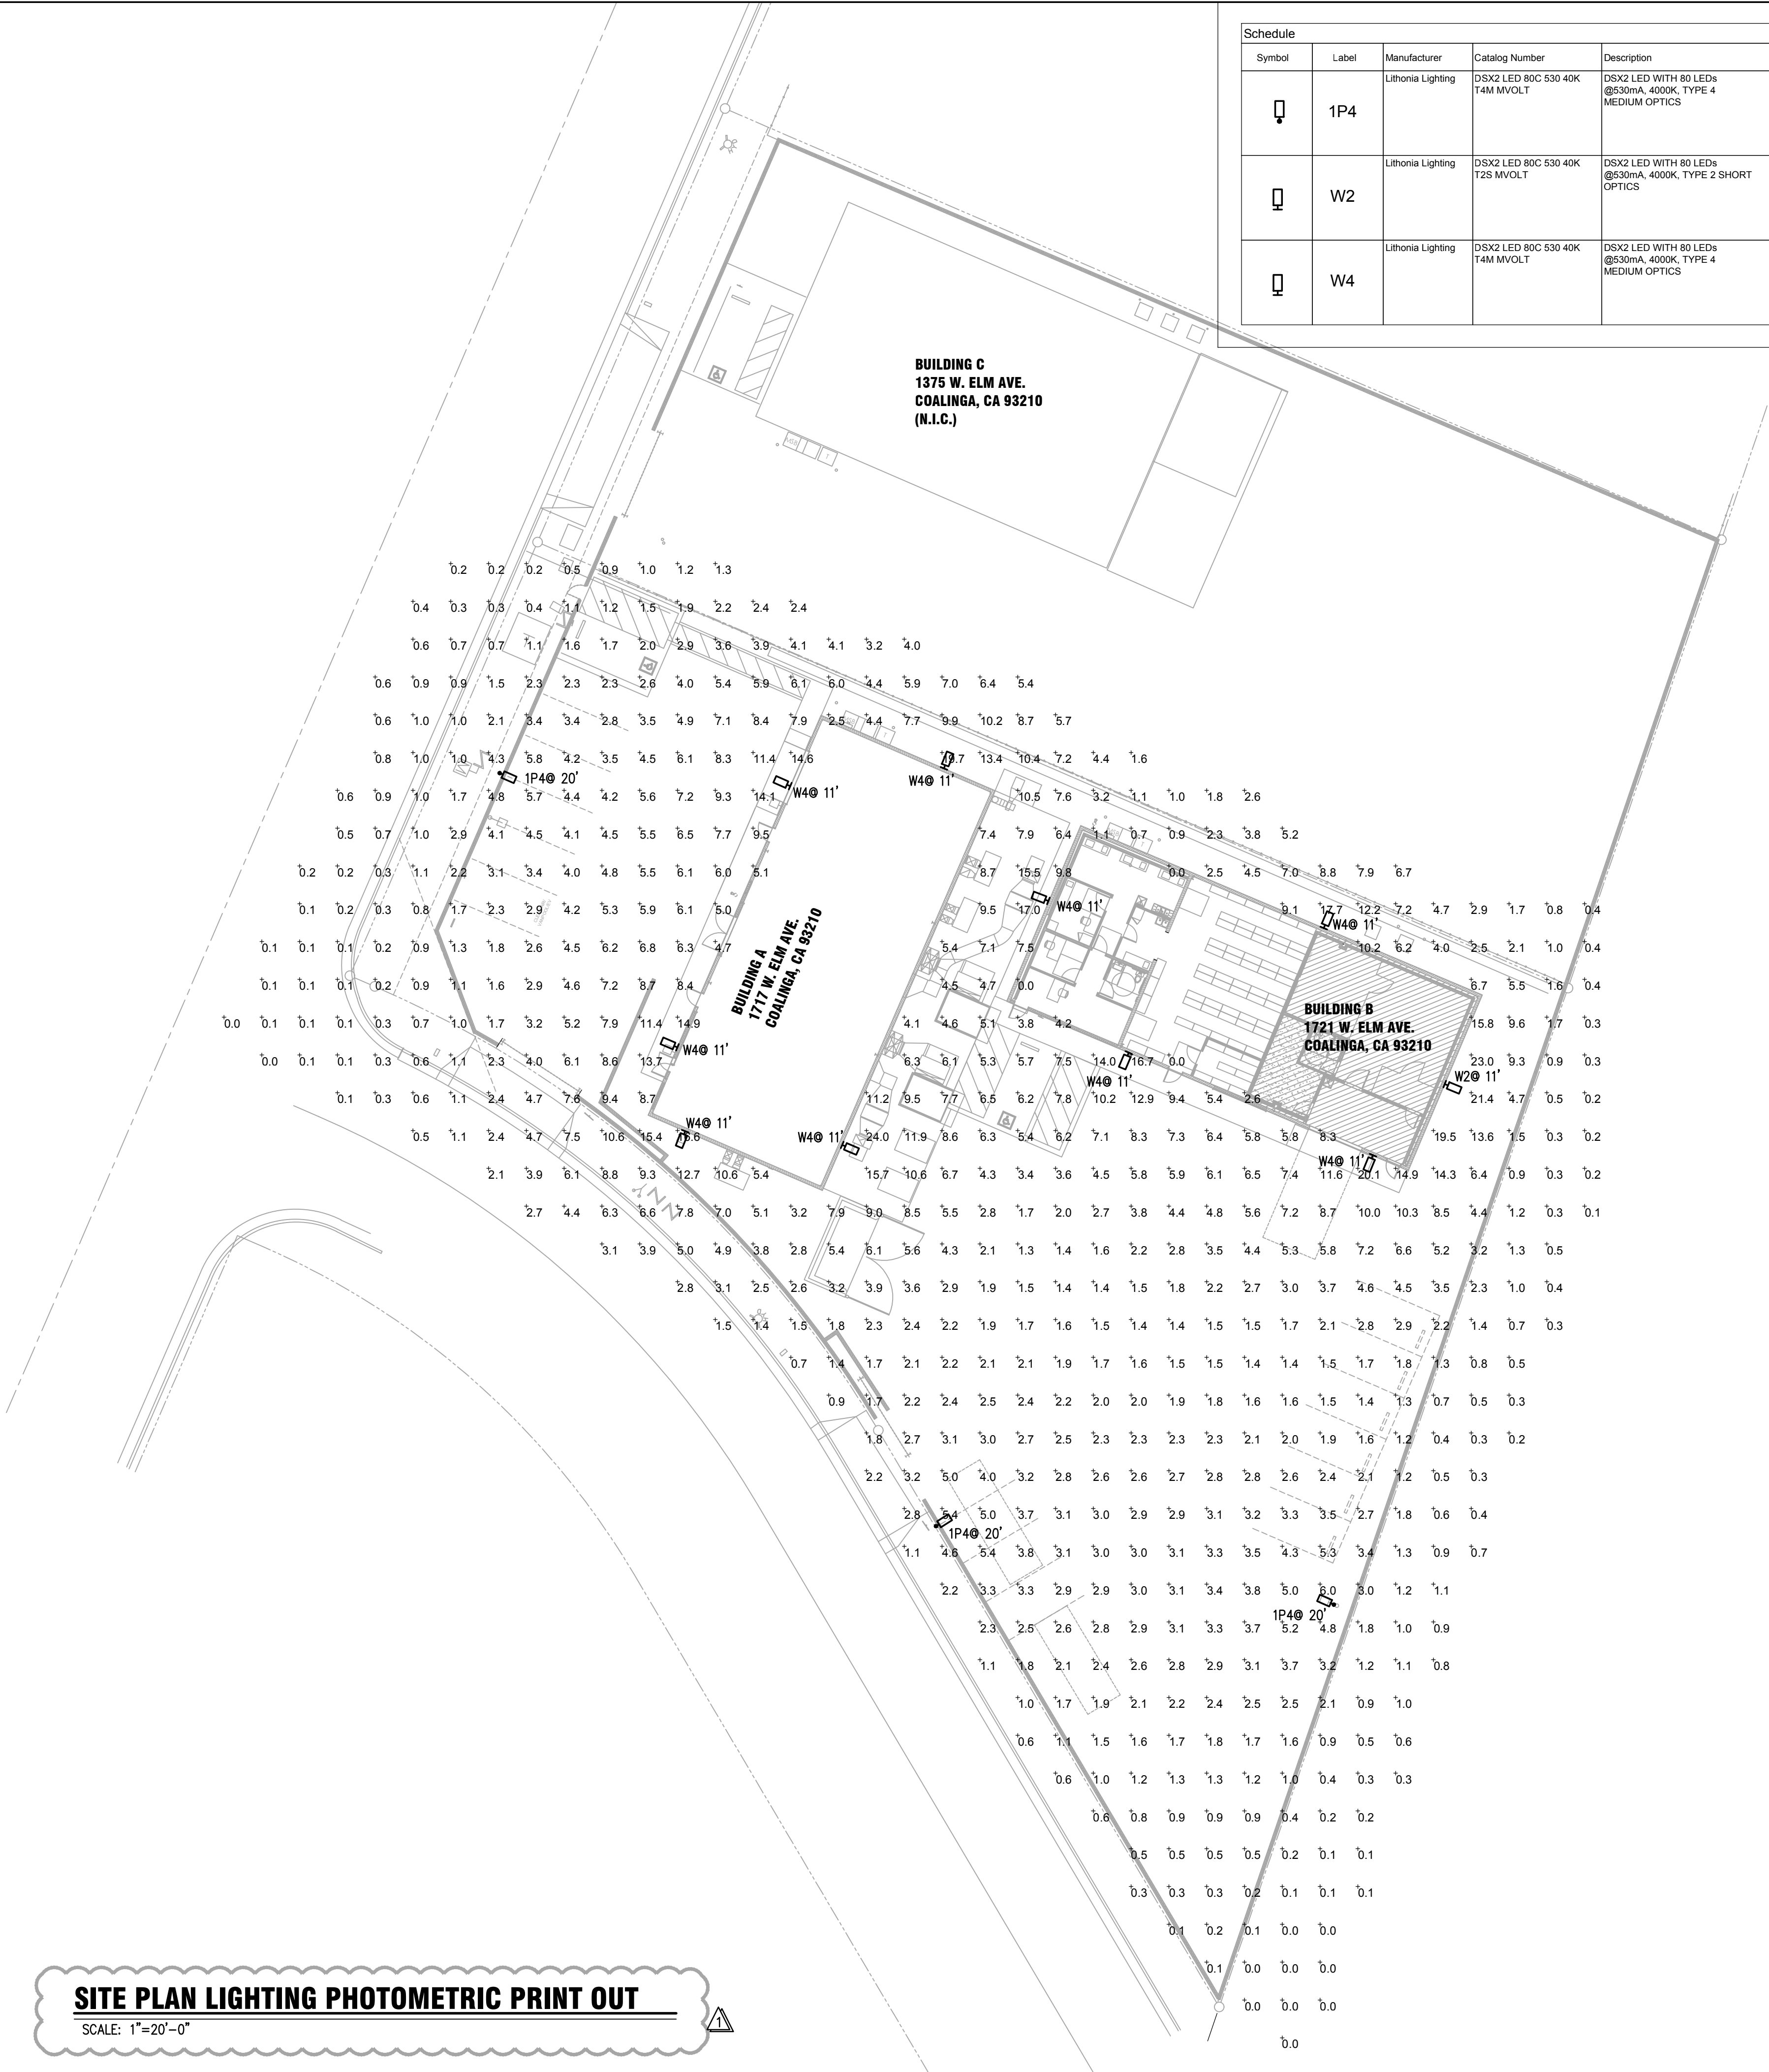

Schedule									
Symbol	Label	Manufacturer	Catalog Number	Description	Lamp	Filename	Lumens Per Lamp	Light Loss Factor	Wattage
	1P4	Lithonia Lighting	DSX2 LED 80C 530 40K T4M MVOLT	DSX2 LED WITH 80 LEDs @530mA, 4000K, TYPE 4 MEDIUM OPTICS	LED	DSX2_LED_80C_530_40K_T4M_M VOLT.ies	17082	0.95	137
	W2	Lithonia Lighting	DSX2 LED 80C 530 40K T2S MVOLT	DSX2 LED WITH 80 LEDs @530mA, 4000K, TYPE 2 SHORT OPTICS	LED	DSX2_LED_80C_530_40K_T2S_M VOLT.ies	17114	0.95	137
	W4	Lithonia Lighting	DSX2 LED 80C 530 40K T4M MVOLT	DSX2 LED WITH 80 LEDs @530mA, 4000K, TYPE 4 MEDIUM OPTICS	LED	DSX2_LED_80C_530_40K_T4M_M VOLT.ies	17082	0.95	137

BARNUM & CELILLO




ELECTRIC, INC.

A Hands-On Contractor From Conception to Completion

CORPORATE HEADQUARTERS

135 Main Ave
Sacramento, CA 95838
PH (916)666-4661 FX (916)666-0819
License #059724

COMMERCIAL ELECTRICAL
& CONTRACTING SERVICES
SINCE 1990

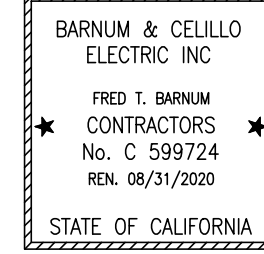

The ideas, drawings, designs and specifications incorporated herein serve as an instrument of service and is the property of Barnum & Celillo Electric Inc. and is not to be used in whole or in part for any project without the written authorization of Barnum & Celillo Electric Inc.

Re-use, publication or reproduction by any method in whole or in part is prohibited. Title to the plans and specifications remain with Barnum & Celillo Electric, Inc., without prejudice pursuant to the provisions of chapter 9 of division 3 of the business and professions code.

These plans and specifications are the property of Barnum & Celillo Electric Inc. for their exclusive use and not intended for posting purposes. Barnum & Celillo Electric, Inc. assumes any responsibility for the plans accuracy and contents if used by anyone other than Barnum & Celillo Electric Inc.

THESE DRAWINGS AND SPECIFICATIONS HAVE BEEN PREPARED BY BARNUM AND CELILLO ELECTRIC, INC. FOR THE EXCLUSIVE DESIGN-BUILD USE IN ACCORDANCE WITH SECTION 9507.2 OR 9733.3 OF THE CALIFORNIA BUSINESS AND PROFESSIONS CODE AND SHALL NOT BE USED BY ANY OTHER CONTRACTOR.

ISSUE RECORD

DESIGN NUMBER

PROJECT NUMBER

4290

DATE

10-16-17

PROJECT MANAGER

FB

DRAWN BY

LHS

CHECKED BY

FB

PROJECT

WEST ELM EXTRACTION
FACILITY NORTH AND
SOUTH

W. ELM AVENUE
COALINGA, CA 93210

REVISION

NO.	DESCRIPTION	DATE
1	SITE REVISION	3-4-19

SHEET TITLE

SITE PLAN -
PHOTOMETRIC
PRINT OUT

SHEET NUMBER

E4.0

OF 8